

FINISH SCHEDULE					
ROOM NAME	FLOOR	BASE	WALL	CEILING	01-11-19
100 DINING ROOM	T200 24" X 24" TILE	T109 6" X 48" TILE	P101, P104 T109 W102 PAINT TILE WALL COVERING	C1 2' X 2' ARMSTRONG, SEPIA #PN81311 C3 GYP BOARD W/ PAINT P103	
101 SERVING AREA	S1 SILIKAL FLOORING S2 IN HIGH TRAFFIC AREAS	S1 AND S2 6" CONT. MIN (KITCHEN EQUIPMENT ON 6" NSF APPROVED LEGS)	T109 TILE	C3 GYP BOARD W/ SMOOTH WASHABLE PAINT	
102 DRIVE-THRU STATION	S1 SILIKAL FLOORING S2 IN HIGH TRAFFIC AREAS	S1 AND S2 6" CONT. MIN (KITCHEN EQUIPMENT ON 6" NSF APPROVED LEGS)	WP1 FRP PANEL	C2 2' X 4' SUSPENDED GRID WASHABLE VINYL COATED GYP BOARD PANELS	
103 KITCHEN	S1 SILIKAL FLOORING S2 IN HIGH TRAFFIC AREAS	S1 AND S2 6" CONT. MIN (KITCHEN EQUIPMENT ON 6" NSF APPROVED LEGS)	WP3 S.S. BEHIND COOK LINE WP1 FRP PANEL	C2 2' X 4' SUSPENDED GRID WASHABLE VINYL COATED GYP BOARD PANELS	
104 KITCHEN PREP.	S1 SILIKAL FLOORING S2 IN HIGH TRAFFIC AREAS	S1 AND S2 6" CONT. MIN (KITCHEN EQUIPMENT ON 6" NSF APPROVED LEGS)	WP1 FRP PANEL	C2 2' X 4' SUSPENDED GRID WASHABLE VINYL COATED GYP BOARD PANELS	
105 WALK-IN COOLER	S1 SILIKAL FLOORING S2 IN HIGH TRAFFIC AREAS	S.S. / ALUMINUM WITH 3/4" RADIUS	EXT S.S. INT ALUMINUM GALVANIZED S.S.	ALUMINUM GALVANIZED STAINLESS STEEL	
105A WALK-IN FREEZER	GALVANIZED STAINLESS STEEL S2 SILIKAL UNDER WIF SUBFLOOR	S.S. / ALUMINUM WITH 3/4" RADIUS	EXT S.S. INT ALUMINUM GALVANIZED S.S.	ALUMINUM GALVANIZED STAINLESS STEEL	
106 MEN'S ROOM	T200 24" X 24" TILE	SCHLUTER	T108 TILE	C3 GYB BOARD W/ P101 SMOOTH WASHABLE PAINT	
107 WOMEN'S ROOM	T200 24" X 24" TILE	SCHLUTER	T108 TILE	C3 GYB BOARD W/ P101 SMOOTH WASHABLE PAINT	
108 VESTIBULE	T200 24" X 24" TILE	T109 6" X 48" TILE	P104 PAINT GYB BOARD T109 TILE	C3 GYB BOARD W/ P101 SMOOTH WASHABLE PAINT	
109 STORAGE ROOM	T200 24" X 24" TILE	T109 6" X 48" TILE	WP1 FRP PANEL	C3 GYB BOARD W/ P101 SMOOTH WASHABLE PAINT	
110 BACK ROOM	SEALED CONCRETE, SMOOTH FINISH	.	EPOXY PAINT, COLOR TO MATCH P9As	OPEN P9As (TRUSSES AND ROOF DECK)	
111 UTILITY ROOM	SEALED CONCRETE SMOOTH FINISH	EXISTING	EXISTING	OPEN	

DOOR & HARDWARE SCHEDULE									
INSTALLED AND FURNISHED BY: G.C. UNLESS NOTED OTHERWISE									
NO.	DOOR MATERIAL	SIZE	FRAME	FACE/EDGE	THK.	CORE	LITE	RATE	REMARKS
01	ALUMINUM STOREFRONT	3'-0" X 7'-0" EXT.		CLEAR ANODIZE TO MATCH EXISTING					
02	ALUMINUM STOREFRONT	EXISTING EXT.		EXISTING TO REMAIN					PROVIDE PULL ON EXTERIOR SIDE
03	S.C. WOOD	3'-0" X 7'-0" H. MT.		PLASTIC LAMINATE PRE-FINISHED	1 3/4"	SOLID	-	-	
04	S.C. WOOD	3'-0" X 7'-0" H. MT.		PLASTIC LAMINATE PRE-FINISHED	1 3/4"	SOLID	-	-	
05	HOLLOW METAL	3'-6" X 7'-0" H. MTL.		PAINTED	1 3/4"	INSUL.	-	-	KICKPLATE ON INT. SIDE OF DOOR
05A	HOLLOW METAL	6'-0" X 7'-0" H. MT.		PAINT DOOR AND FRAME	1 3/4"	INSUL.	-	-	KICKPLATE ON INT. SIDE OF DOOR
05B	EXISTING HOLLOW METAL	EXISTING EXT.		PAINT DOOR AND FRAME					

 
WALL SCHEDULE		INSTALLED AND FURNISHED BY: G.C. UNLESS NOTED OTHERWISE	
NO.	DESCRIPTION		
01	3-5/8" 20GA. METAL STUD WALL W/ 1/2" TYPE "X" GYP. BOARD BOTH SIDES (SEE ARCHITECTURAL DETAILS & ELEVATIONS)		
02	3-5/8" 20GA. METAL STUD WALL W/ 1/2" TYPE "X" GYP. BOARD ON ONE SIDE (SEE ARCHITECTURAL DETAILS & ELEVATIONS)		
03	NEW 6" WOOD FRAMING FLUSH AND ALIGNED WITH EXISTING, NEW EXTERIOR SHEATHING, AND R-20 BATT INSULATION AND 1/2" TYPE "X" GYP BOARD ON INTERIOR		
04	3-5/8" 20GA. METAL STUD LOW WALL W/ 1/2" TYPE "X" GYP. BD BOTH SIDES. PROVIDE 3/4" KNEE-WALL BRACE/POST @ CORNERS AND @ 48" O.C.		
05	6" 20GA. METAL STUD WALL W/ 1/2" TYPE "X" GYP. BOARD OVER 3/8" STRUCTURAL SHEATHING ON BOTH SIDES (SEE ARCHITECTURAL DETAILS & ELEVATIONS), WOOD STUD 2X6 AT SIM. CONDITION.		
06	6" 20GA. METAL STUD WALL W/ 1/2" TYPE "X" GYP. BOARD ONE SIDE (SEE ARCHITECTURAL DETAILS & ELEVATIONS) OVER EXISTING WALL FRAMING		
07	2 1/2" 20GA. METAL STUD WITH 2 LAYERS OF GYP. BD. ON HOOD SIDE. EXISTING WOOD FRAMED WALL RECEIVES 1 LAYER OF 1/2" TYPE X GYP. BD. BEFORE METAL STUD WALL.		
08	EXISTING FRAMING; INSTALL NEW R-20 BATT INSULATION AND NEW 1/2" GYP. BOARD; AT SIM INSTALL R-20 BATT ONLY		

 
WALL PANEL SCHEDULE				
INSTALLED AND FURNISHED BY: G.C. UNLESS NOTED OTHERWISE				
NO	MANUFACTURER	DESCRIPTION	MFG #	REMARK
WP1	CRANE COMPOSITES INC.	F.R.P. THICKNESS: .075	LBGS.14	CONTACT: LINDA RUSE 310.857.9036
WP2	-	S.S. PANEL (22 GA)	-	BRUSHED FINISH FURNISHED BY PX, INSTALLED BY G.C.
WP3	-	S.S. PANEL (22 GA)	-	DIAMOND PATTERN FINISH FURNISHED BY PX, INSTALLED BY G.C.
WP4	NOT USED			
WP6	NOT USED			
W101	NOT USED			
W102	WOLF GORDON	PRINT WALLCOVERING	-	CONTACT: CATHY DY 310.770.1165 cathy.dy@wolfgordon.com
W103	WOLF GORDON	CLOUD WALLCOVERING	-	CONTACT: CATHY DY 310.770.1165 cathy.dy@wolfgordon.com


SPECIAL SURFACE SCHEDULE				
INSTALLED AND FURNISHED BY: G.C. UNLESS NOTED OTHERWISE				
NO	MANUFACTURER	PRODUCT	MFG #	REMARK
Q2-5	NOT USED			
Q2-6	NOT USED			
Q2-7	CORIAN	ARTIFICIAL QUARTZ	-	SERVICE COUNTER & DRINK STATION PROVIDED BY PX, INSTALLED BY G.C.


INTERIOR PAINT SCHEDULE				
INSTALLED AND FURNISHED BY: G.C. UNLESS NOTED OTHERWISE				
NO	MANUFACTURER	MFG #	COLOR	REMARK
P9As	SHERWIN-WILLIAMS	SW 7065	ARGOS	PROMAR 200, ZERO VOC, LATEX SEMI-GLOSS REAR SERVICE DOOR
P9B	NOT USED			
P101	SHERWIN-WILLIAMS	SW 6252	ICE CUBE	PROMAR 200, ZERO VOC, LATEX EGG-SHELL RESTROOM & RESTROOM VESTIBULE CEILING, SERVICE LINE SOFFIT
P102	NOT USED			
P103	SHERWIN-WILLIAMS	SW 7032	WARM STONE	PROMAR 200, ZERO VOC, LATEX EGG-SHELL DROPPED SOFFITS
P104	SHERWIN-WILLIAMS	SW 6155	RICE GRAIN	PROMAR 200, ZERO VOC, LATEX EGG-SHELL DINING RM. WALLS, RESTROOM VESTIBULE WALLS
P105	NOT USED			
P106	SHERWIN-WILLIAMS	SW 7020	BLACK FOX	DTM ACRYLIC GLOSS, LOW VOC RESTROOM DOOR FRAMES & LCD NICHE (BACK WALL)
P205	SHERWIN-WILLIAMS	SW 7675	SEALSKIN	PROMAR 200, ZERO VOC, LATEX EGG-SHELL FRONT & BACK & UNDERSIDE FACES OF SERVICE COUNTER SOFFIT


WALL LEGEND

 
 EXISTING WALL

 NEW INTERIOR FURRING WALL FRAMED WITH STRUCTURAL STEEL STUDS

 NEW INTERIOR WALL (FULL HT.)

 NEW INTERIOR WALL (LOW WALL - REF. ELEV. & DETAILS)

 WALK-IN BOX PANEL

 
 NEW WOOD FRAMED EXTERIOR WALL

 
NOTE: THE FOLLOWING STAINLESS STEEL PROVIDED BY PX-INSTALLED BY G.C.:


- PANEL DIVIDERS AT WP3
- INSIDE CORNER AT WP3 TO WP2
- FLASHING AT TOP OF BASE WP3
- WP2 PIECE AT LENGTH OF WALL

NOTE: THE FOLLOWING STAINLESS STEEL PROVIDED BY G.C.-INSTALLED BY G.C.:

- INSTALL 18 GA STAINLESS STEEL CORNER GUARD & WALL CAP INSIDE KITCHEN

 18 GA. STAINLESS STEEL CORNER GUARD - FULL HT.

 18 GA. STAINLESS STEEL CORNER GUARD/FRAME - ALL AROUND PERIMETER OF OPENING - FRAME TO BE WELDED WITH MITERED CORNERS TO FORM SINGLE UNIT.

 18 GA. STAINLESS STEEL WALL CAP

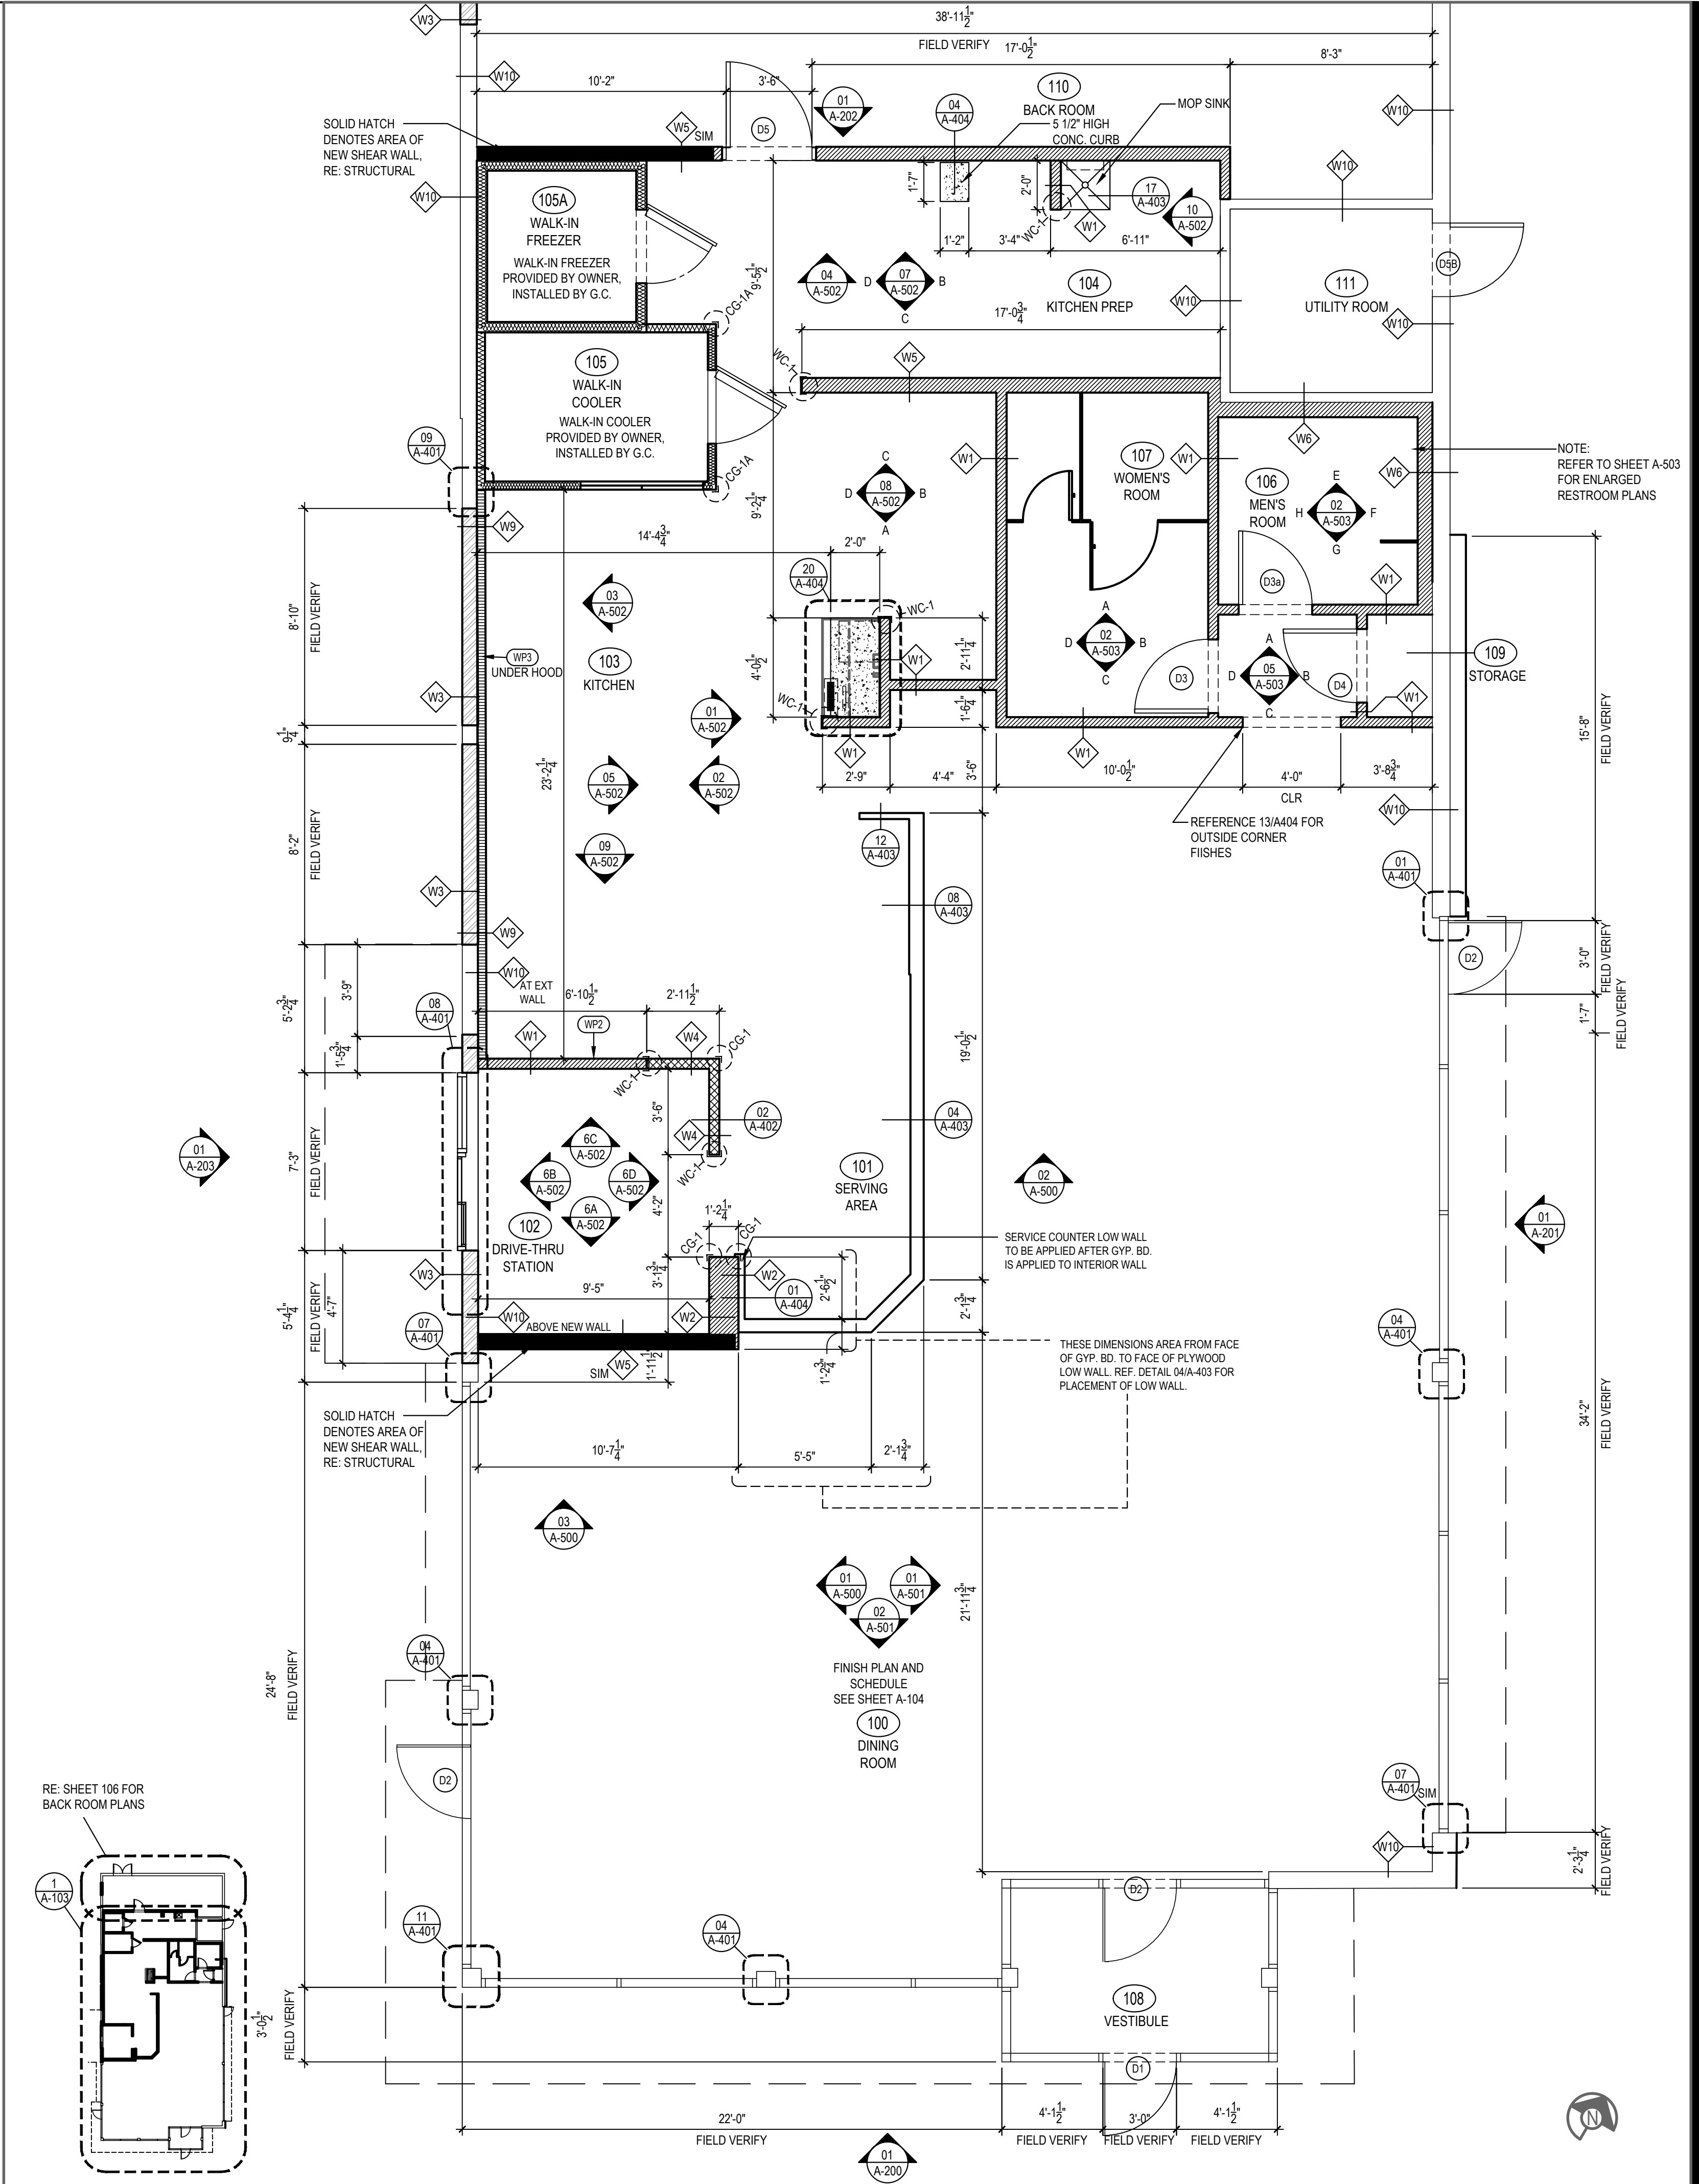
ALL OTHER STAINLESS STEEL BY G.C.

NOTE:
*ALL INTERIOR DIMENSIONS ARE FACE OF GYPSUM BOARD TO GYPSUM BOARD

*AT "D3a" PROVIDE PRIVACY LOCK

*AT "D3a" PROVIDE PRIVACY LOCK

TILE SCHEDULE (SEE SHEET A-104)



PANDA EXPRESS, INC.
1683 Walnut Grove Ave.
Rosemead, California
91770
Telephone: 626.799.9898
Facsimile: 626.372.8288

All ideas, designs, arrangement and plans indicated or represented by this drawing are the property of Panda Express Inc. and were created for use on this specific project. None of these ideas, designs, arrangements or plans may be used by or disclosed to any person, firm, or corporation without the written permission of Panda Express Inc.

REVISIONS:

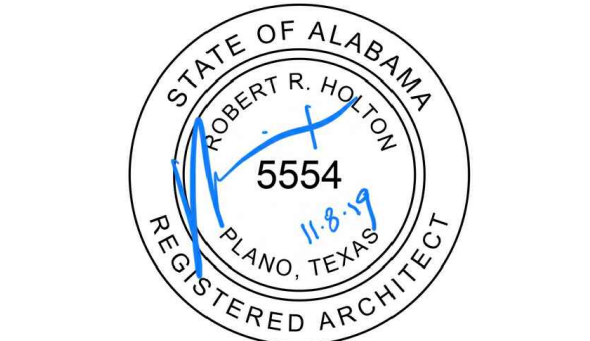
ISSUE DATE:

1st	DEVELOPER REVIEW	07.26.19
2nd	SITE PLAN SUBMITTAL	08.26.19
3rd	SITE COMMENTS	09.05.19
4th	ISSUE FOR PERMIT	10.01.19
5th	ISSUE FOR BID	11.07.19

DRAWN BY: PM / KL / EA

PANDA PROJECT #: S8-20-D7163

ARCH PROJECT #: 19027



Heights Venture
ARCHITECTURE ♦ DESIGN

HOUSTON 1111 North Loop West, Suite 800
Houston, Texas 77028
713.869.1163 V

DALLAS 5741 Legacy Drive, Suite 320
Plano, Texas 75024
972.490.7292 V

PANDA EXPRESS

2096 INTERSTATE DR.
OPELIKA, AL 36801
3600 FSDT
TWW REMODEL

A-103
FLOOR PLAN

TRUE WARM & WELCOME

BID ISSUE